


LEGEND:-	
	BULLET TYPE CAMERA 15
	POWER SUPPLY UNIT 15
	6A UPS POWER SOCKET 18
	24 PORT SWITCH 01
	CAT- 6 CABLE (APPROX.) 560

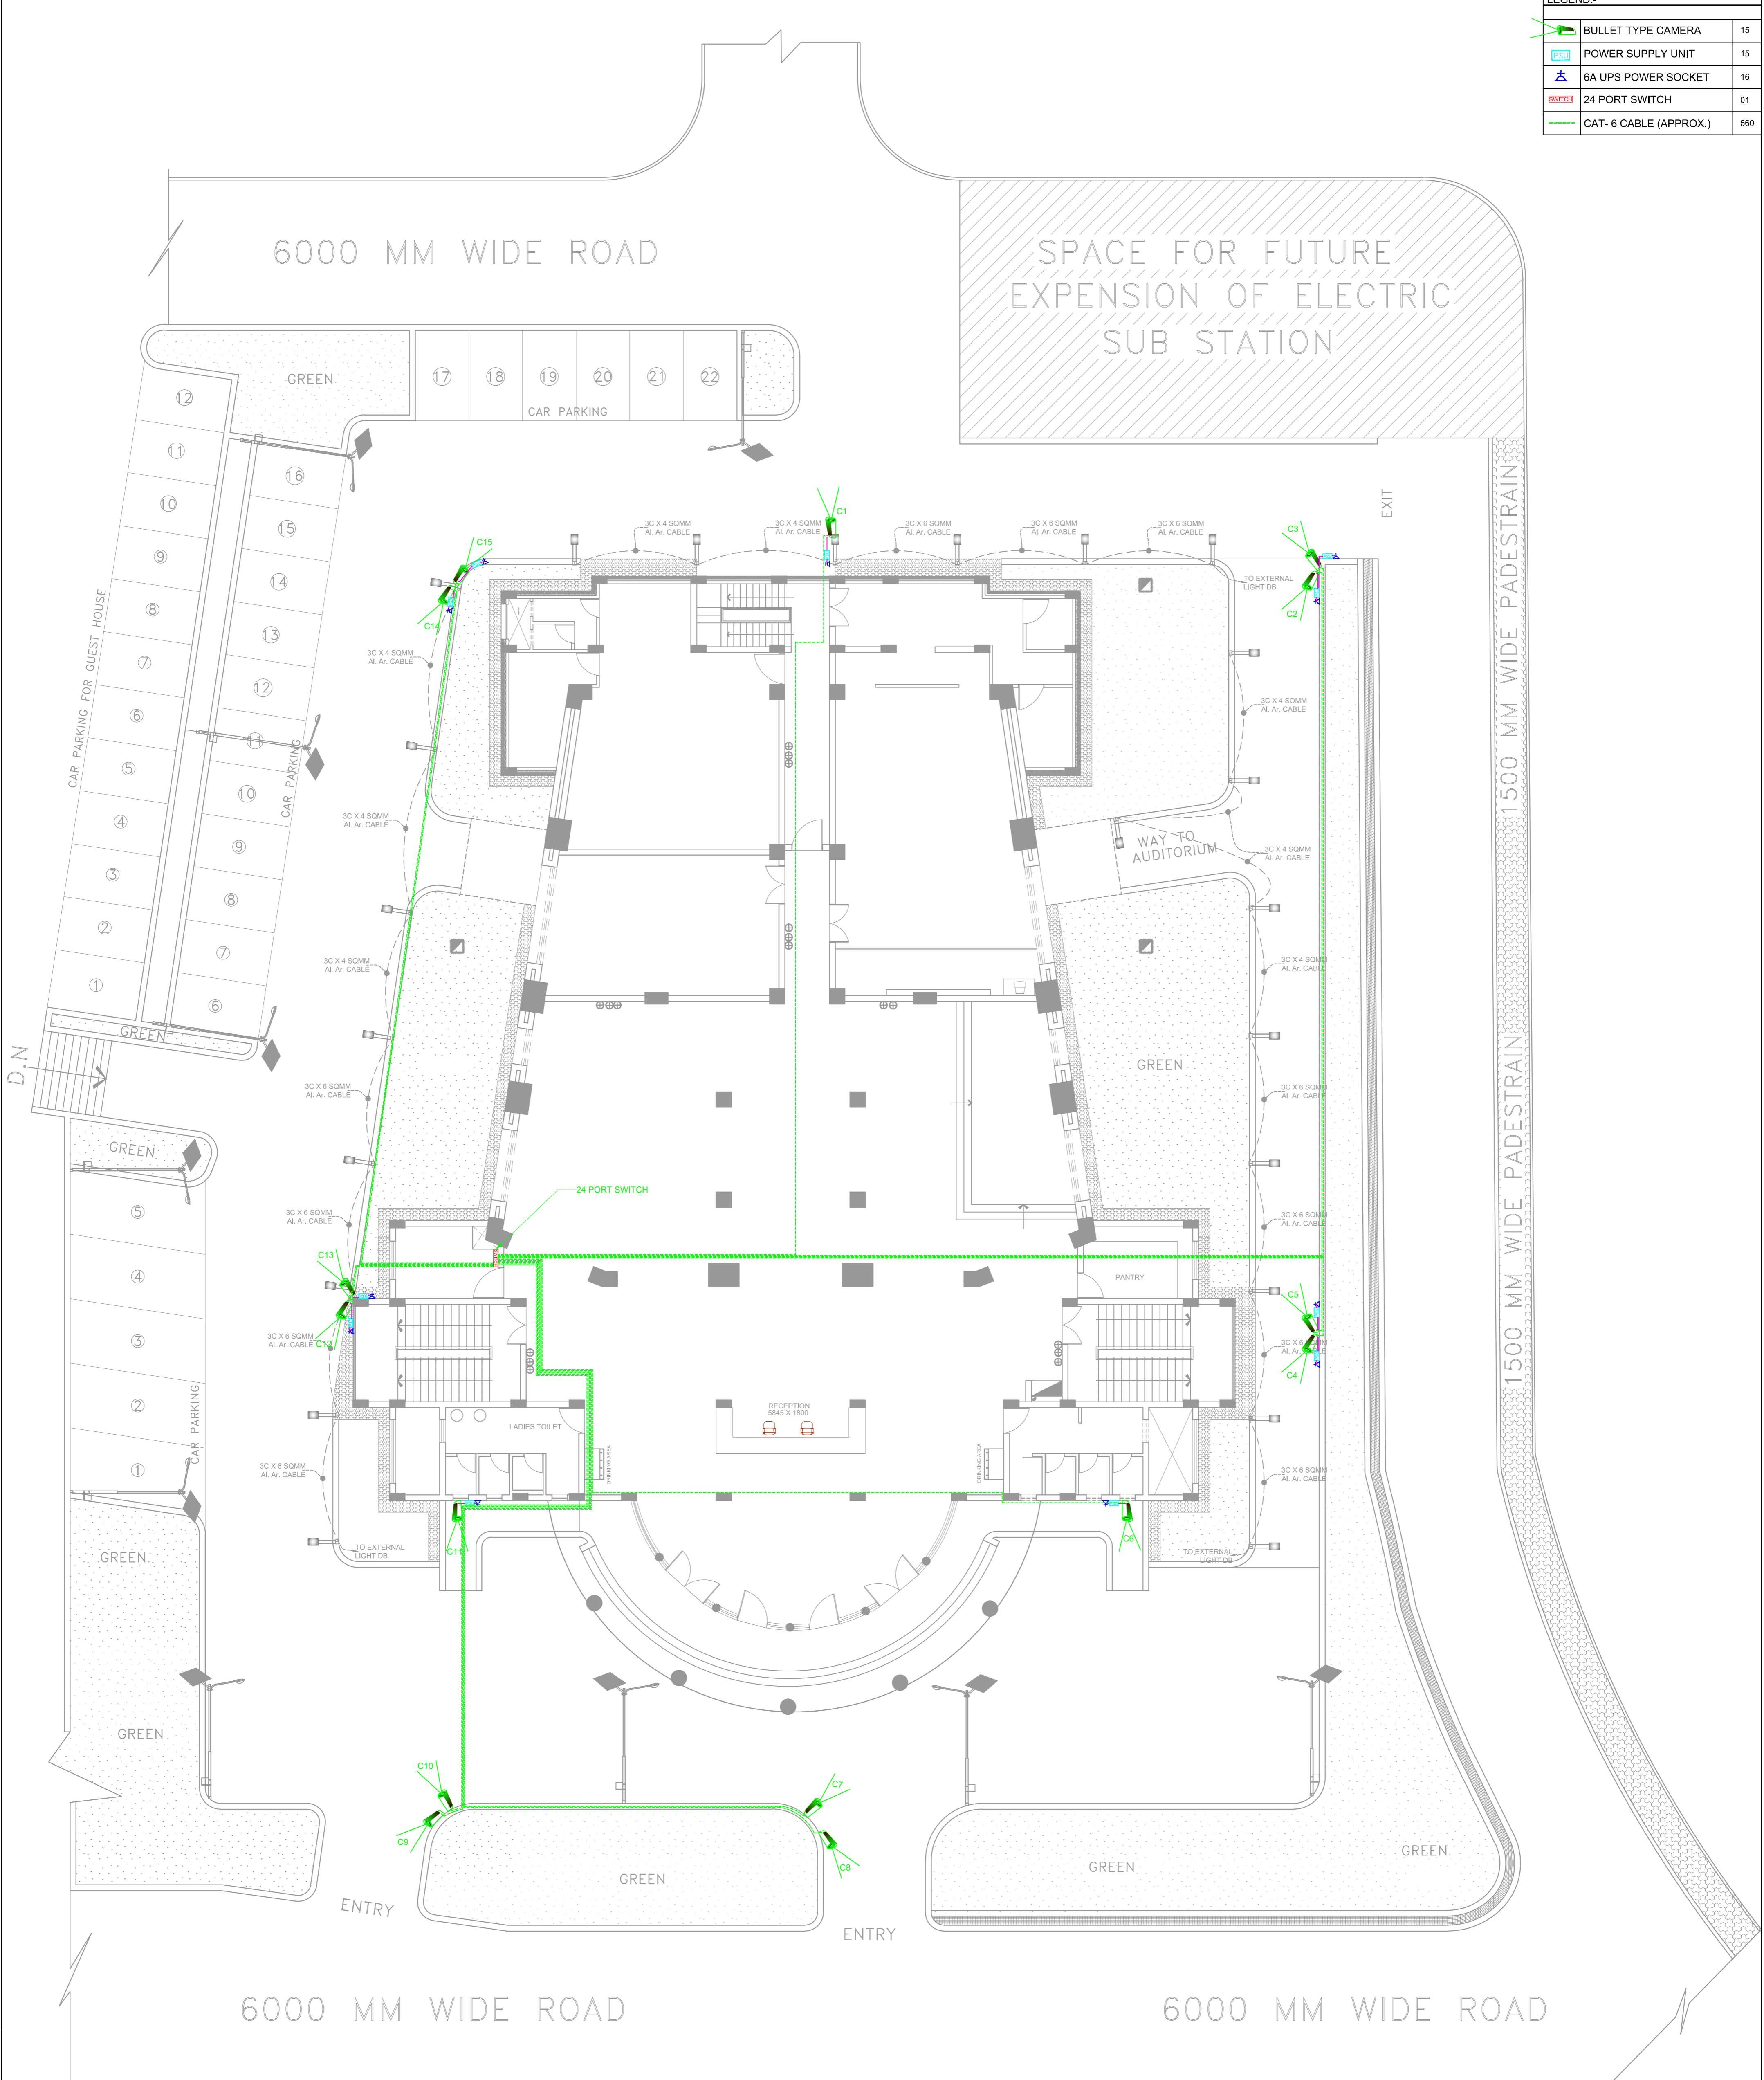

PRODUCED BY AN AUTODESK EDUCATIONAL PRODUCT

PRODUCED BY AN AUTODESK EDUCATIONAL PRODUCT

S.NO.	REVISION DATE	REMARKS



PROJECT :-  
**AUDITORIUM FOR I.U.A.C  
 OF 300+ SEATING  
 CAPACITY AT I.U.A.C  
 CAMPUS , NEW DELHI.**

MEP Consultant:-  
**M.S ASSOCIATES**  
 MEP CONSULTANT ENGINEERS  
 B-400, Gali No.-10, Veerbazar Road  
 Near Krishna Dramsala,  
 Gaurav Nagar, Prem Nagar Part-II,  
 Nangloi, New Delhi-110086  
 E-Mail: msassociates95@gmail.com,  
 ajay20051978@yahoo.com  
 Tel. 09213274289, 09555954522

PRINCIPAL CONSULTANT :-  
 RITES Ltd.  
 A Government of India Enterprises  
 CLIENT :-  
**I.U.A.C.**

ASSOCIATE CONSULTANT :-  
  
**MATHUR  
 UGAM AND ASSOCIATES**  
 A1/294, SAFDARJUNG ENCLAVE  
 NEW DELHI-110029  
 PH. NO.-(011) 26108436, 26100971  
 FAX No.-26185711  
 NS-EN ISO 9001:2008/ISO 9001:2008

SHEET TITLE :-  
**CCTV SYSTEM LAYOUT  
 SITE PLAN**

TENDER DRAWING	
DRN KUMAR	DRG. NO.
CHD SINGH	IUAC/RITES/CCTV-01
SCALE	DATE 14/12/2016