


LEGEND:-

(A)	MULTISENSOR DETECTOR ABOVE FALSE CEILING	26
(M)	MULTISENSOR DETECTOR BELOW FALSE CEILING	22
(B)	HEAT DETECTOR	01
(R)	RESPONSE INDICATOR	07
(C)	CONTROL RELAY MODULE	04
(MM)	MONITOR MODULE	02
(S)	CEILING SPEAKER 6W	23
(W)	WALL SPEAKER 24W	06
(MCP)	MANUAL CALL POINT	03
(H)	HOOTER	03
(- - -)	HOOTER CONDUIT	
(- - -)	FIRE ALARM CONDUIT	
(- - -)	SPEAKER CONDUIT	
(- - -)	FIRE FIGHTING TELEPHONE CONDUIT	
(- - -)	TELEPHONE JACK	03

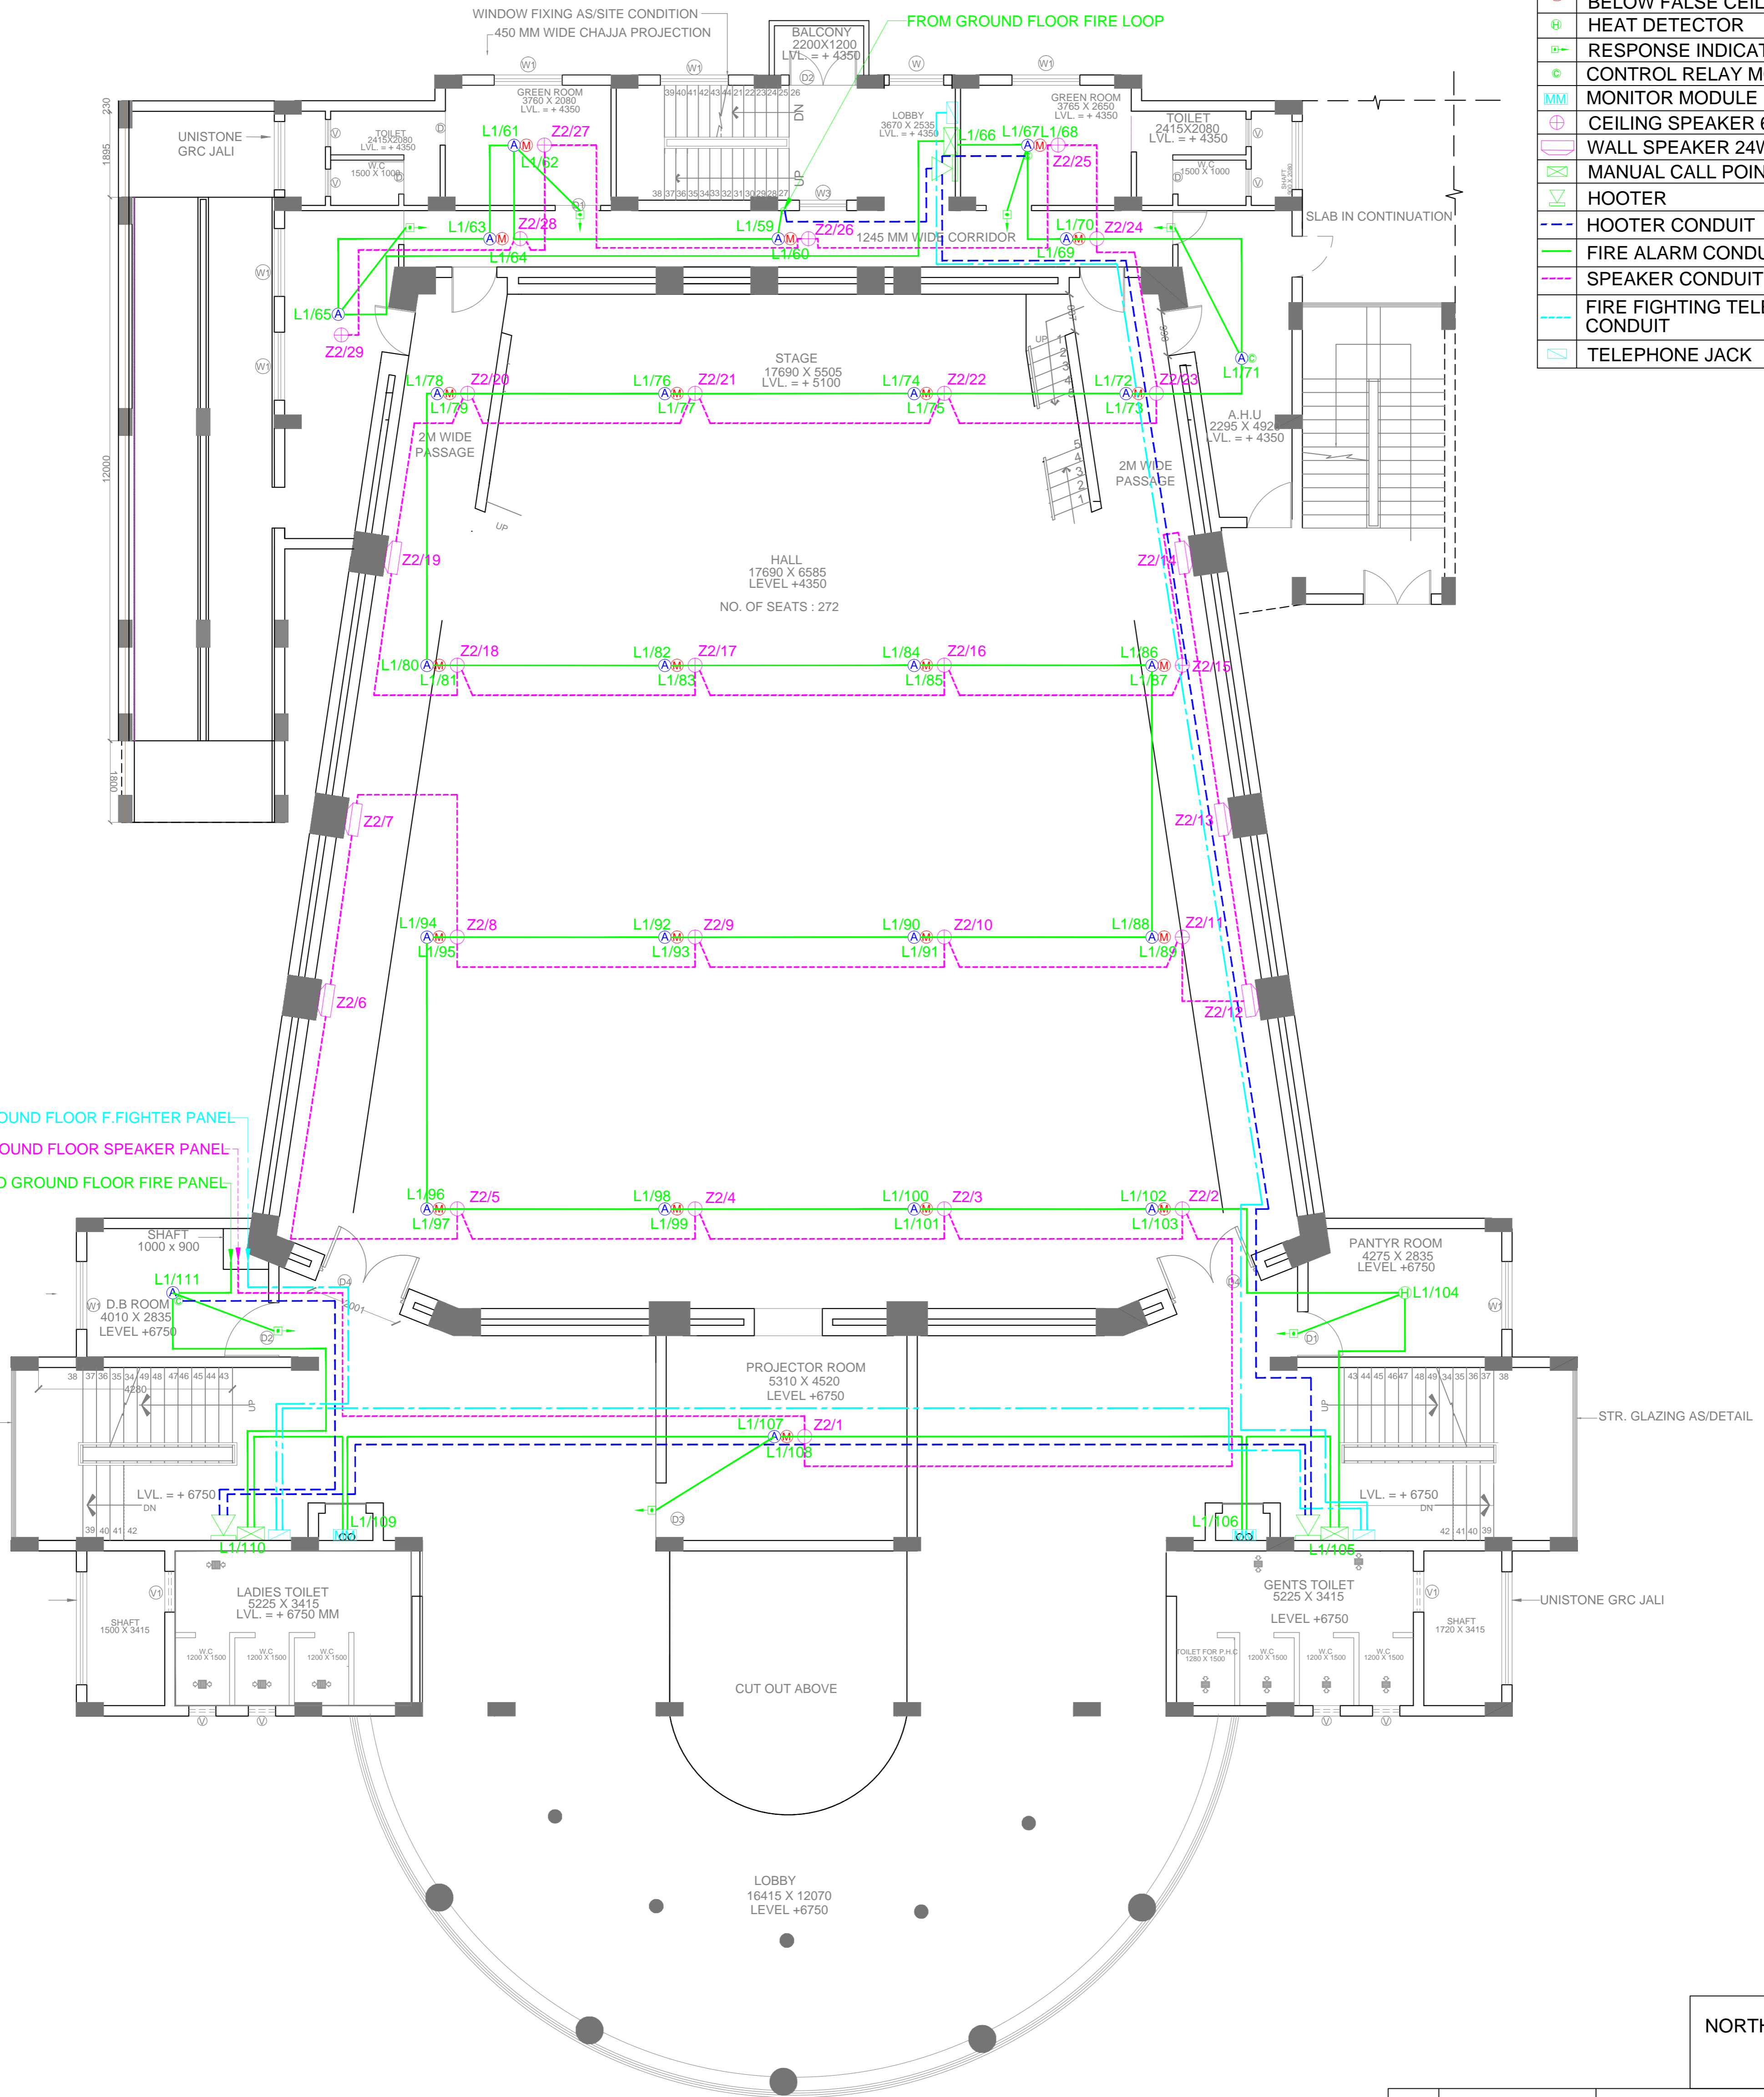

TO GROUND FLOOR F.FIGHTER PANEL
 TO GROUND FLOOR SPEAKER PANEL
 TO GROUND FLOOR FIRE PANEL

S.NO.	REVISION DATE	REMARKS

PROJECT :-
AUDITORIUM FOR I.U.A.C OF 300+ SEATING CAPACITY AT I.U.A.C CAMPUS , NEW DELHI.

MEP Consultant:-
M.S ASSOCIATES
 MEP CONSULTANT ENGINEERS
 B-400, Gali No.-10, Veerbazar Road
 Near Krishna Dramsala,
 Gaurav Nagar, Prem Nagar Part-II,
 Nangloi, New Delhi-110086
 E-Mail: msassociates95@gmail.com,
 ajay20051978@yahoo.com
 Tel. 09213274289, 09555954522

PRINCIPAL CONSULTANT :-
 RITES Ltd.
 A Government of India Enterprises

CLIENT :-
I.U.A.C.

ASSOCIATE CONSULTANT :-



MATHUR UGAM AND ASSOCIATES
 A1/294, SAFDARIJUNG ENCLAVE
 NEW DELHI-110029
 PH. NO.-(011) 26108436, 26100971
 FAX No.:-26185711
 NS-EN ISO 9001:2008/ISO 9001:2008

SHEET TITLE :-
FIRE ALARM SYSTEM FIRST FLOOR

DRG. NO. :-
IUAC/RITES/FIRE ALARM & PA-02

DRN	KUMAR	TENDER DRAWING
CHD	SINGH	
SCALE	----	
DATE	14/12/2016	