



LEGEND:-

	MULTISENSOR DETECTOR ABOVE FALSE CEILING	28
	MULTISENSOR DETECTOR BELOW FALSE CEILING	24
	HEAT DETECTOR	01
	RESPONSE INDICATOR	07
	CONTROL RELAY MODULE	04
	MONITOR MODULE	02
	CEILING SPEAKER	16
	MANUAL CALL POINT	03
	HOOTER	03
	FIRE ALARM CONDUIT	
	SPEAKER CONDUIT	
	FIRE FIGHTING TELEPHONE CONDUIT	
	TELEPHONE JACK	03
	MAIN FIRE CONTROL PANEL	01

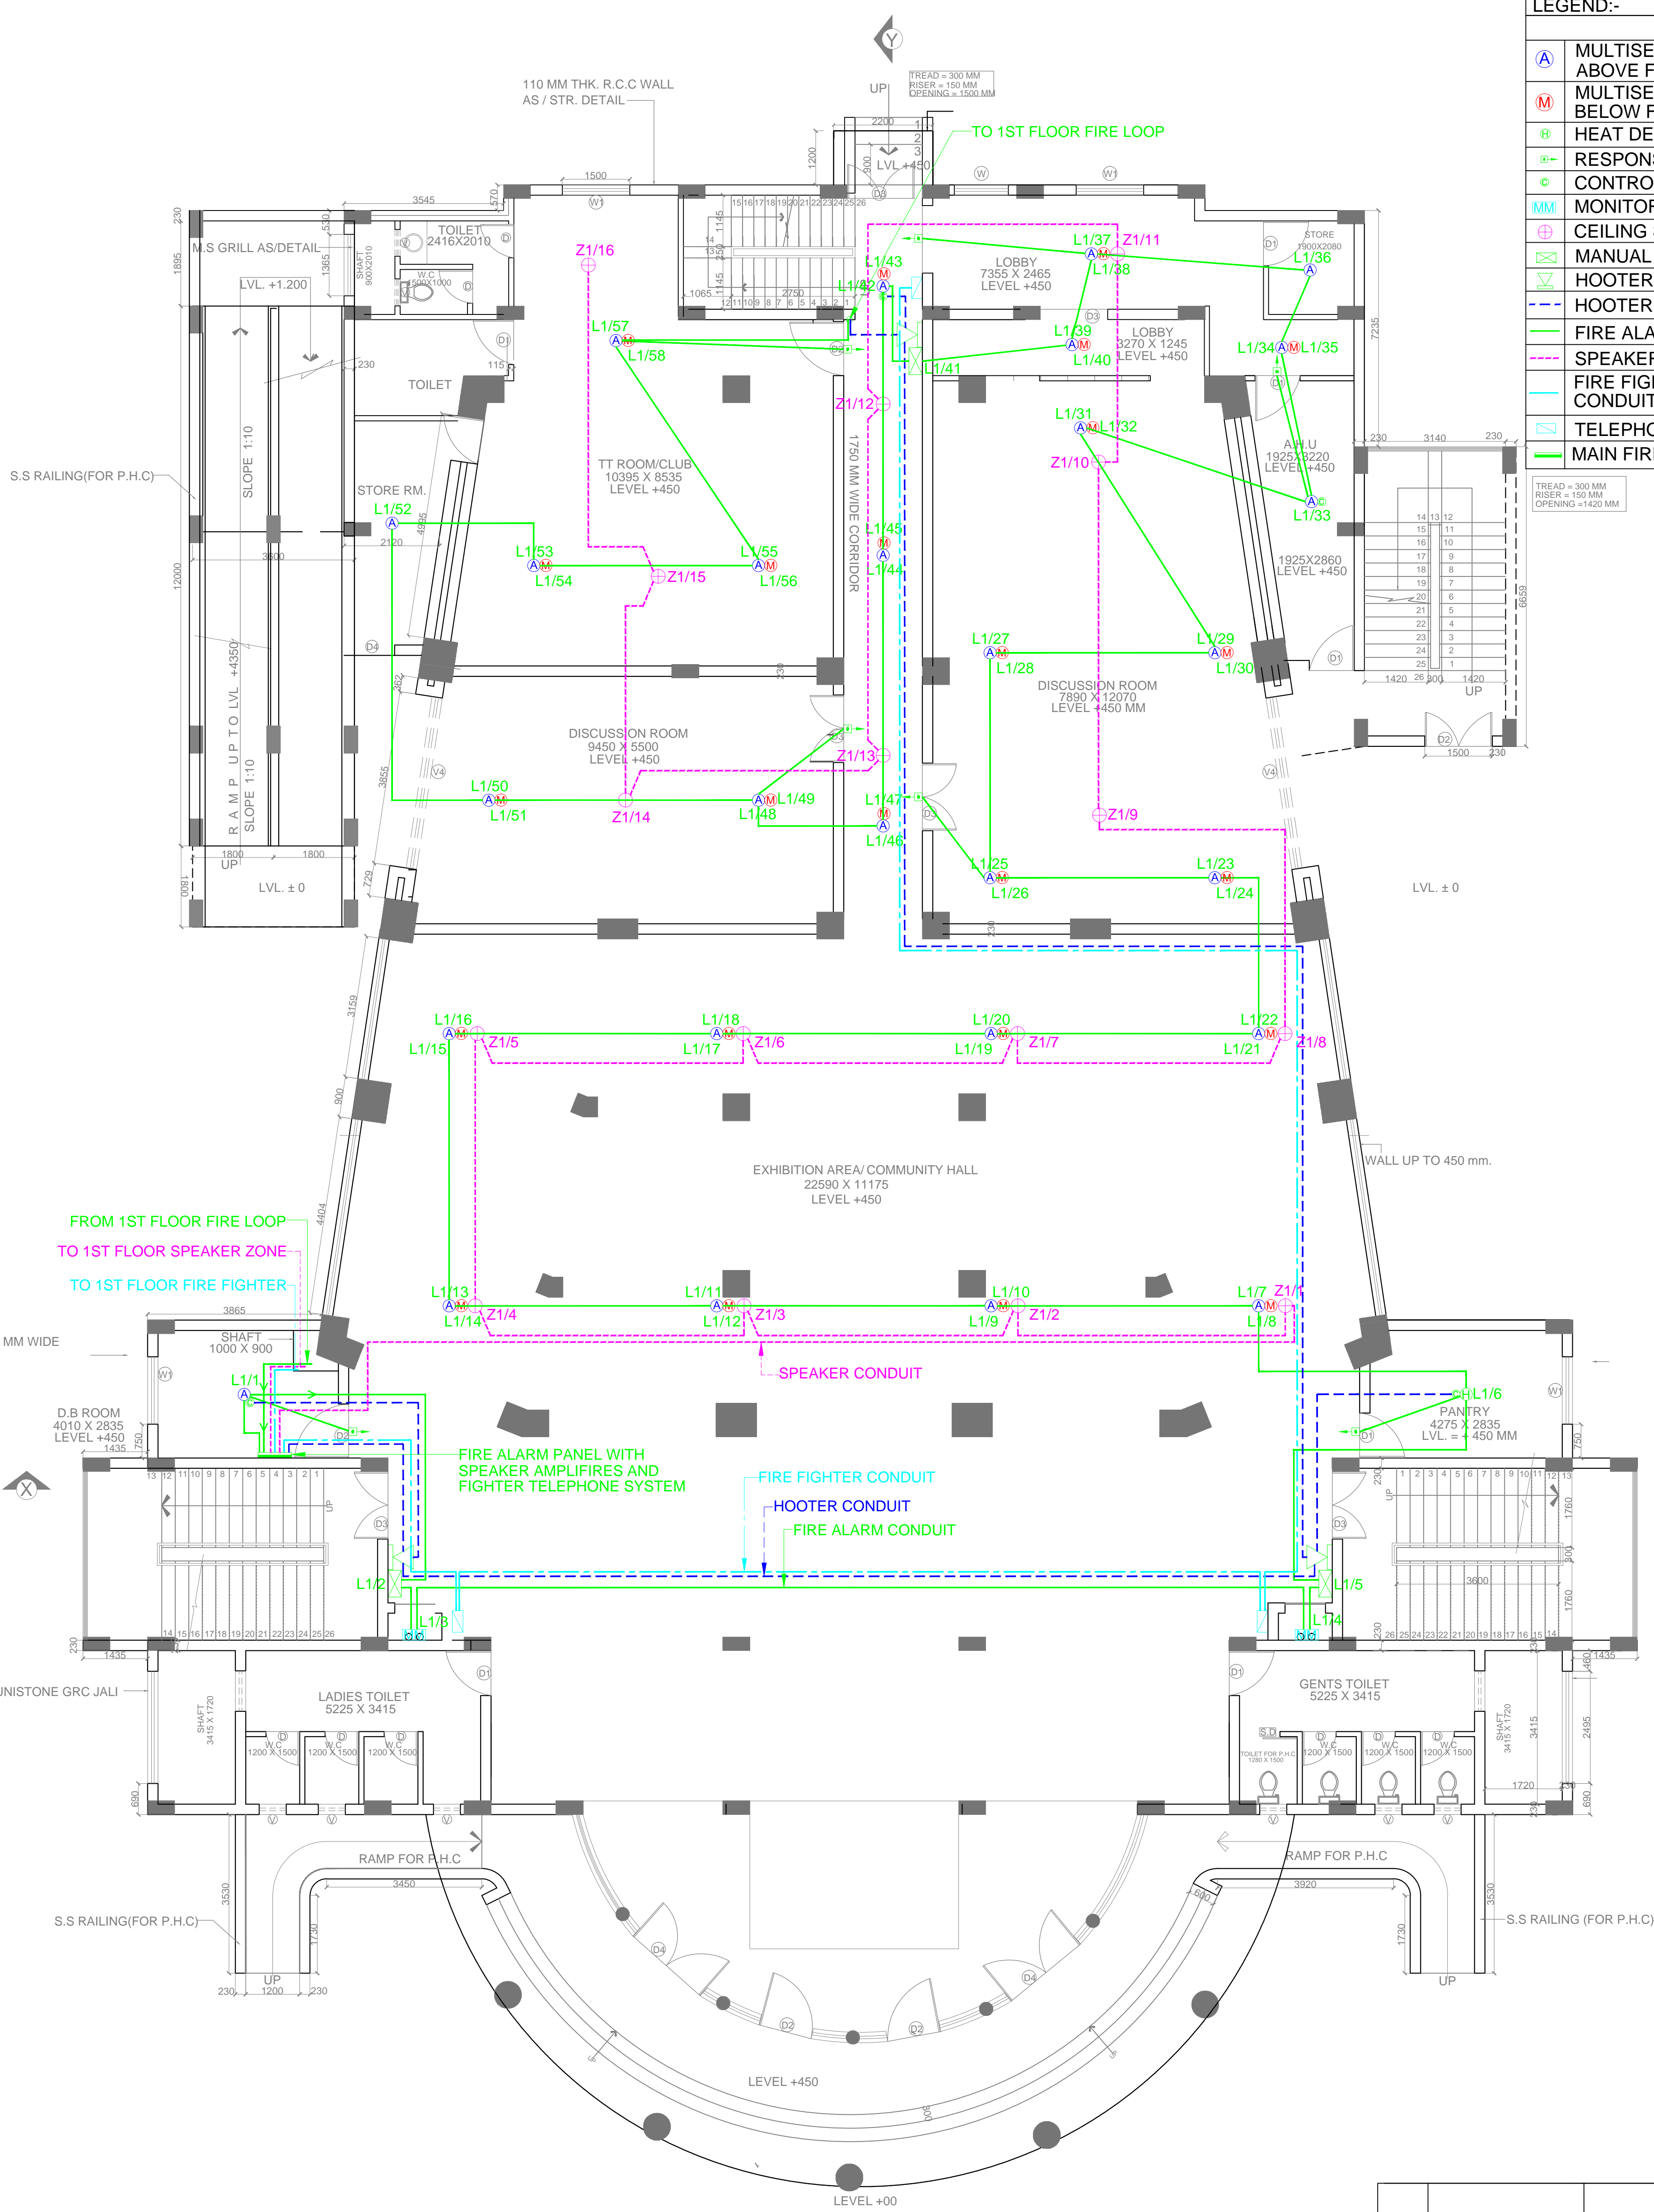

SHOP DRAWING

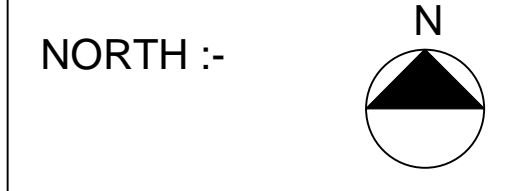

S.NO.	REVISION DATE	REMARKS

PROJECT :-
AUDITORIUM FOR I.U.A.C OF 300+ SEATING CAPACITY AT I.U.A.C CAMPUS , NEW DELHI.

MEP Consultant:-
M.S ASSOCIATES
 MEP CONSULTANT ENGINEERS
 B-400, Gali No.-10, Veerbazar Road
 Near Krishna Dramsala,
 Gaurav Nagar, Prem Nagar Part-II,
 Nangloi, New Delhi-110086
 E-Mail: msassociates95@gmail.com,
 ajay20051978@yahoo.com
 Tel. 09213274289, 09555954522

PRINCIPAL CONSULTANT :-
 RITES Ltd.
 A Government of India Enterprises
 CLIENT :-
I.U.A.C.

ASSOCIATE CONSULTANT :-

MATHUR UGAM AND ASSOCIATES
 A1/294, SAFDARJUNG ENCLAVE
 NEW DELHI-110029
 PH. NO.-(011) 26108436, 26100971
 FAX No.:-26185711
 NS-EN ISO 9001:2008/ISO 9001:2008

SHEET TITLE :-
FIRE ALARM SYSTEM GROUND FLOOR

DRG. NO. :-
 IUAC/RITES/FIRE ALARM & PA -01
 DRN KUMAR
 CHD SINGH
 SCALE -----
 DATE 14/12/2016
 TENDER DRAWING