



LEGEND:-

	VERY FOCAL TYPE CAMERA	11
	FIXED DOME TYPE CAMERA	17
	BULLET TYPE CAMERA	15
	POWER SUPPLY UNIT	43
	6A UPS POWER SOCKET	52
	NETWORK VIDEO RECORDER	02
	24 PORT SWITCH	03
	PC	01
	42" FLAT LED COLOR MONITOR	03
	CAT - 6 CABLE	

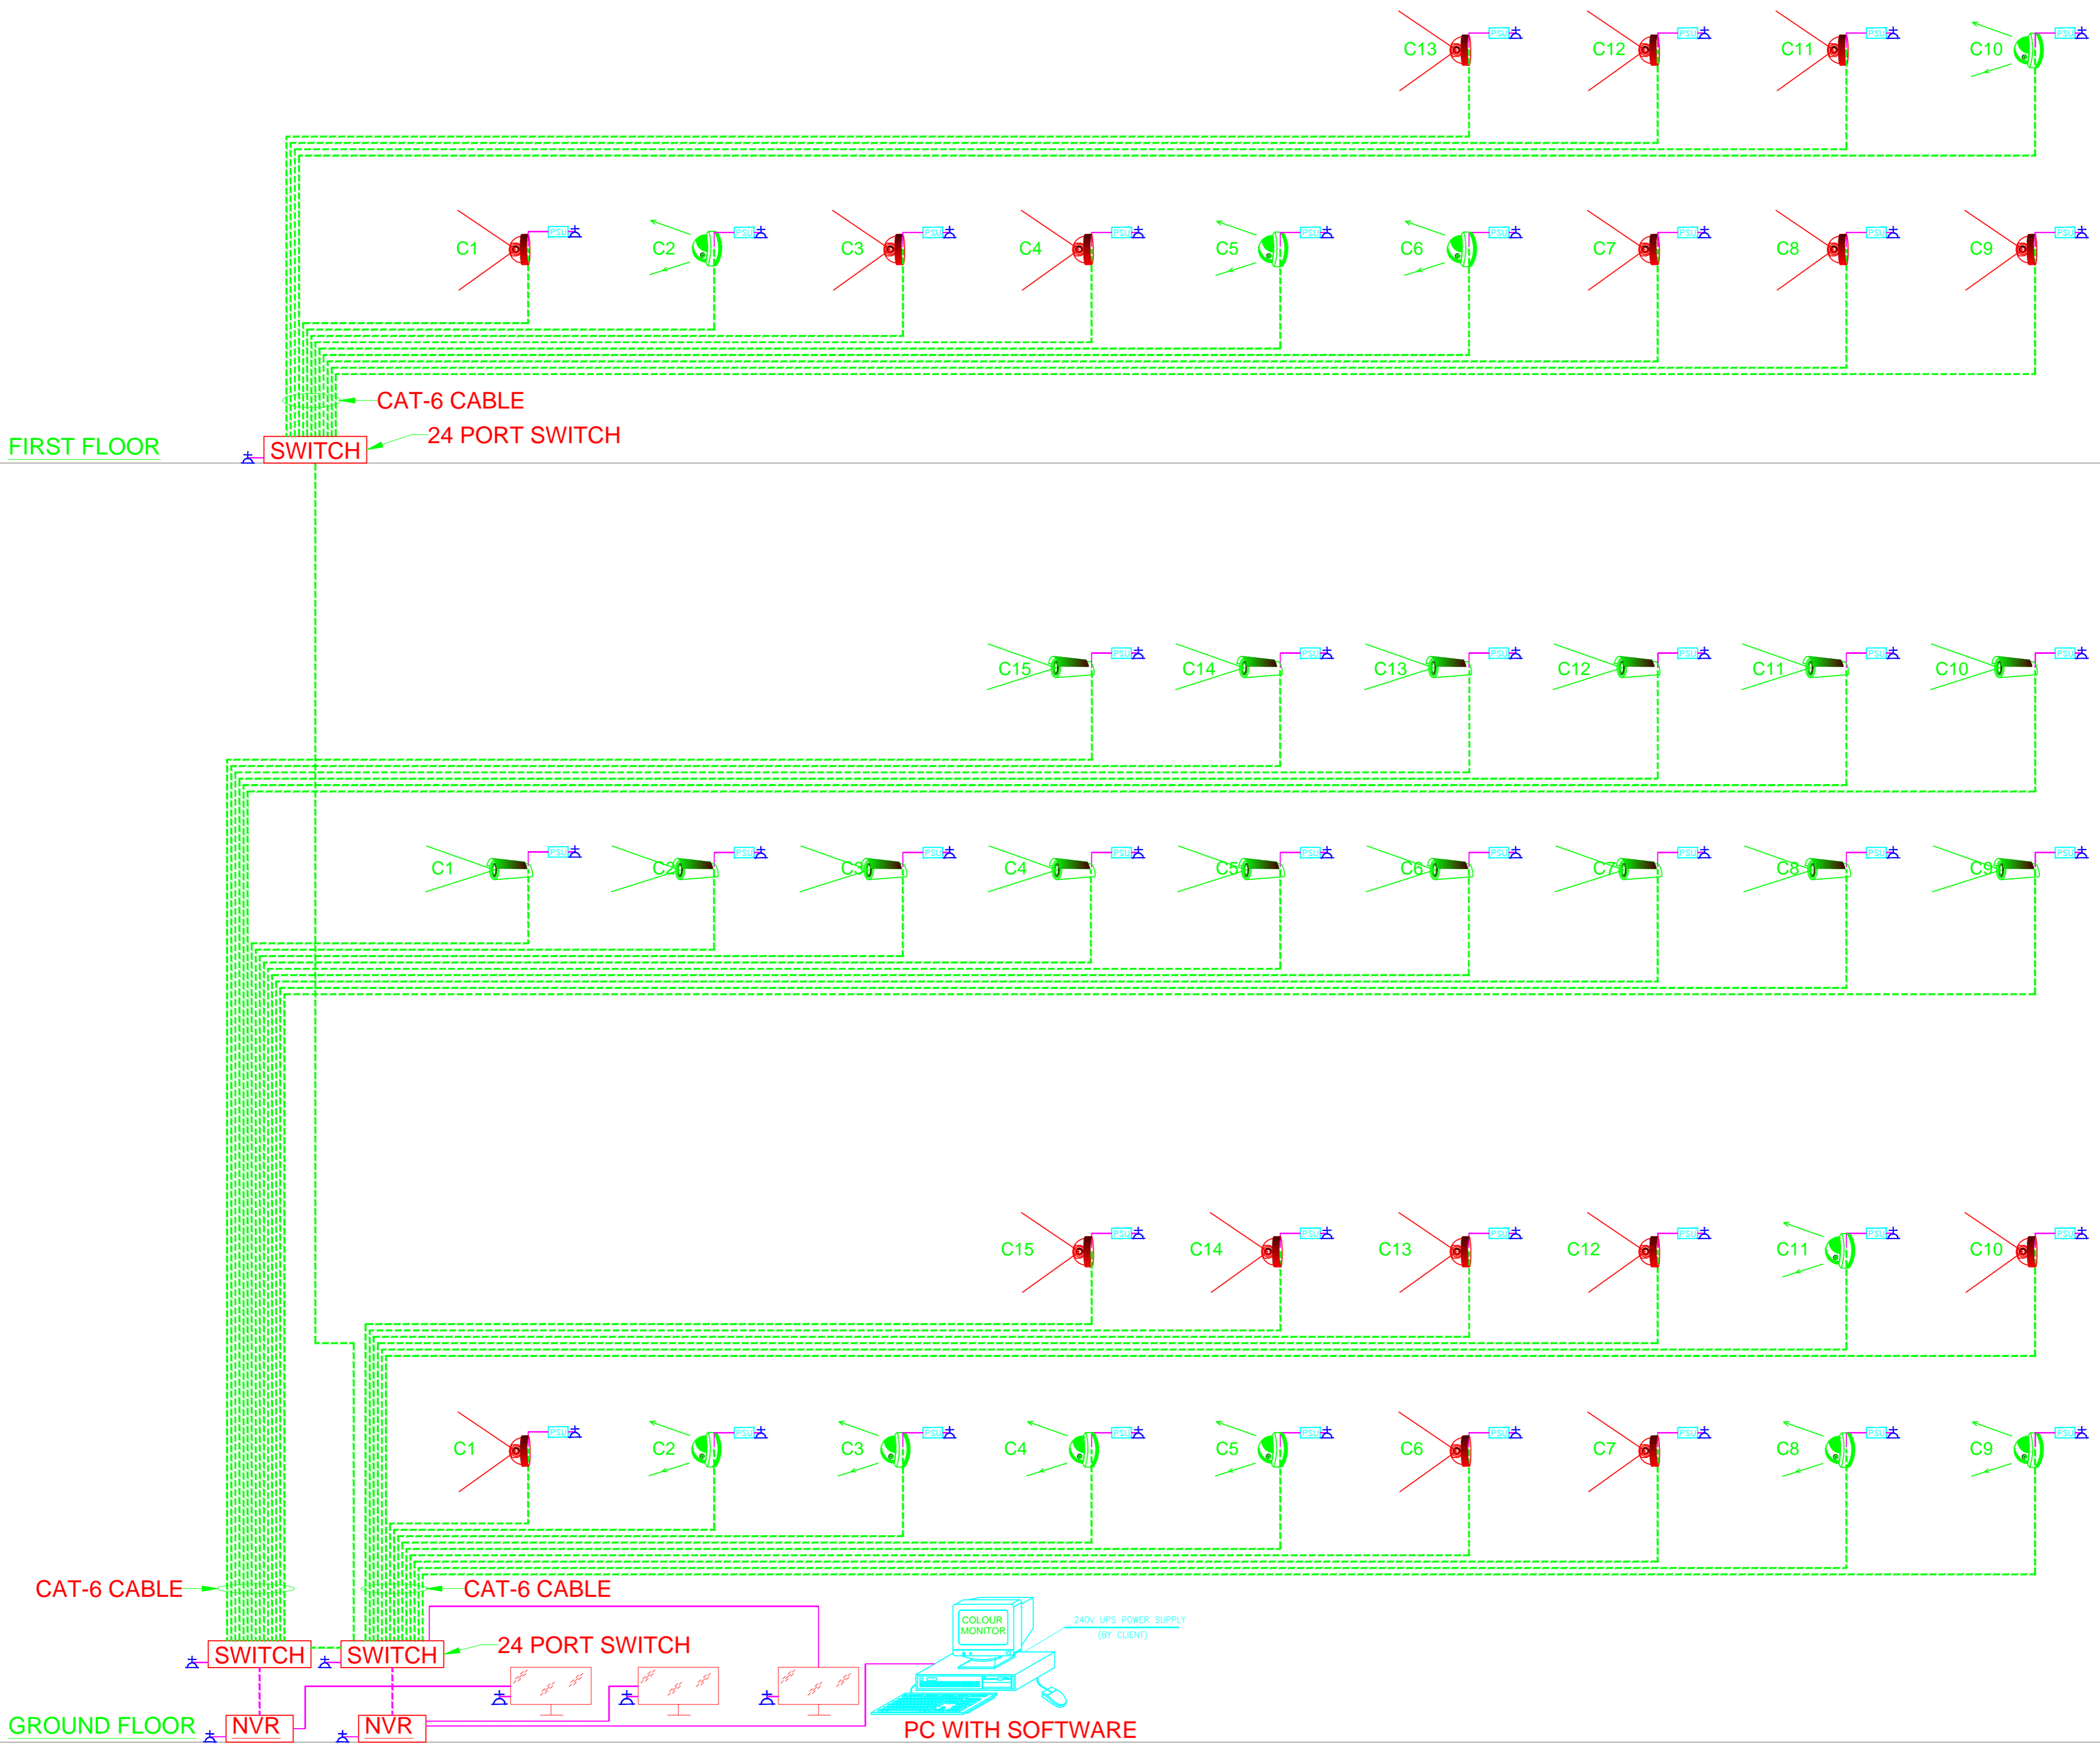

SHOP DRAWING

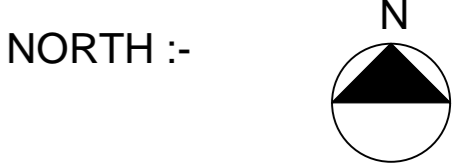

S.NO.	REVISION DATE	REMARKS

PROJECT :-
AUDITORIUM FOR I.U.A.C OF 300+ SEATING CAPACITY AT I.U.A.C CAMPUS , NEW DELHI.

MEP Consultant:-
M.S ASSOCIATES
 MEP CONSULTANT ENGINEERS
 B-400, Gali No.-10, Veerbazar Road
 Near Krishna Dramsala,
 Gaurav Nagar, Prem Nagar Part-II,
 Nangloi, New Delhi-110086
 E-Mail: msassociates95@gmail.com,
 ajay20051978@yahoo.com
 Tel. 09213274289, 09555954522

PRINCIPAL CONSULTANT :-
 RITES Ltd.
 A Government of India Enterprises
 CLIENT :-
I.U.A.C.

ASSOCIATE CONSULTANT :-

MATHUR UGAM AND ASSOCIATES
 A1/294, SAFDARJUNG ENCLAVE
 NEW DELHI-110029
 PH. NO.-(011) 26108436, 26100971
 FAX No.:-26185711
 NS-EN ISO 9001:2008/ISO 9001:2008

SHEET TITLE :-
SINGLE LINE DIAGRAM FOR CCTV SYSTEM

DRG. NO:-
 IUAC/RITES/CCTV/SLD-03

DRN	KUMAR	TENDER DRAWING
CHD	SINGH	
SCALE	----	
DATE	14/12/2016	